



GOVERNMENT OF INDIA

MINISTRY OF ENVIRONMENT, FOREST & CLIMATE CHANGE

Central Zoo Authority

57 By Email &
Registered Post



F. No. 21-2/2003-CZA(418)(Vol. IV)(NS)/168/2016

Email
DATE: 03.02.2016

To

The Director,
Rajiv Gandhi Zoological Park and Wildlife Research Center,
Pune- Satara Road, Opp. Katraj Dairy,
Katraj, Pune- 411 046
Email: rajivgandhizoo@punecorporation.org

Sub:- Revised design of Lion enclosure at Rajiv Gandhi Zoological Park and Wildlife Research Center, Pune- Reg.

Ref:- Your office letter no RGZP- 341, Dated 14.11.2015.

Sir,

With reference to the above cited correspondence the revised design submitted for the proposed construction of enclosure for Lion at Rajiv Gandhi Zoological Park and Wildlife Research Center, Pune was placed before the members of the Expert Group on Zoo Designing of the Central Zoo Authority in its 66th meeting held on 18.01.2016 wherein it was scrutinized and approved.

Keeping in view of the above, please find enclosed herewith the dully signed copy of the design for the proposed construction of enclosure for Lion at Rajiv Gandhi Zoological Park and Wildlife Research Center, Pune for your kind perusal.

Yours faithfully,

Inder Dhamija
3/2/2016


(Inder Dhamija)
DIG(HQ)

with Maps
Encl: as above

Copy to The Commissioner, Pune Municipal Corporation, Pune, Maharashtra for favour of information.

-45-

210 309

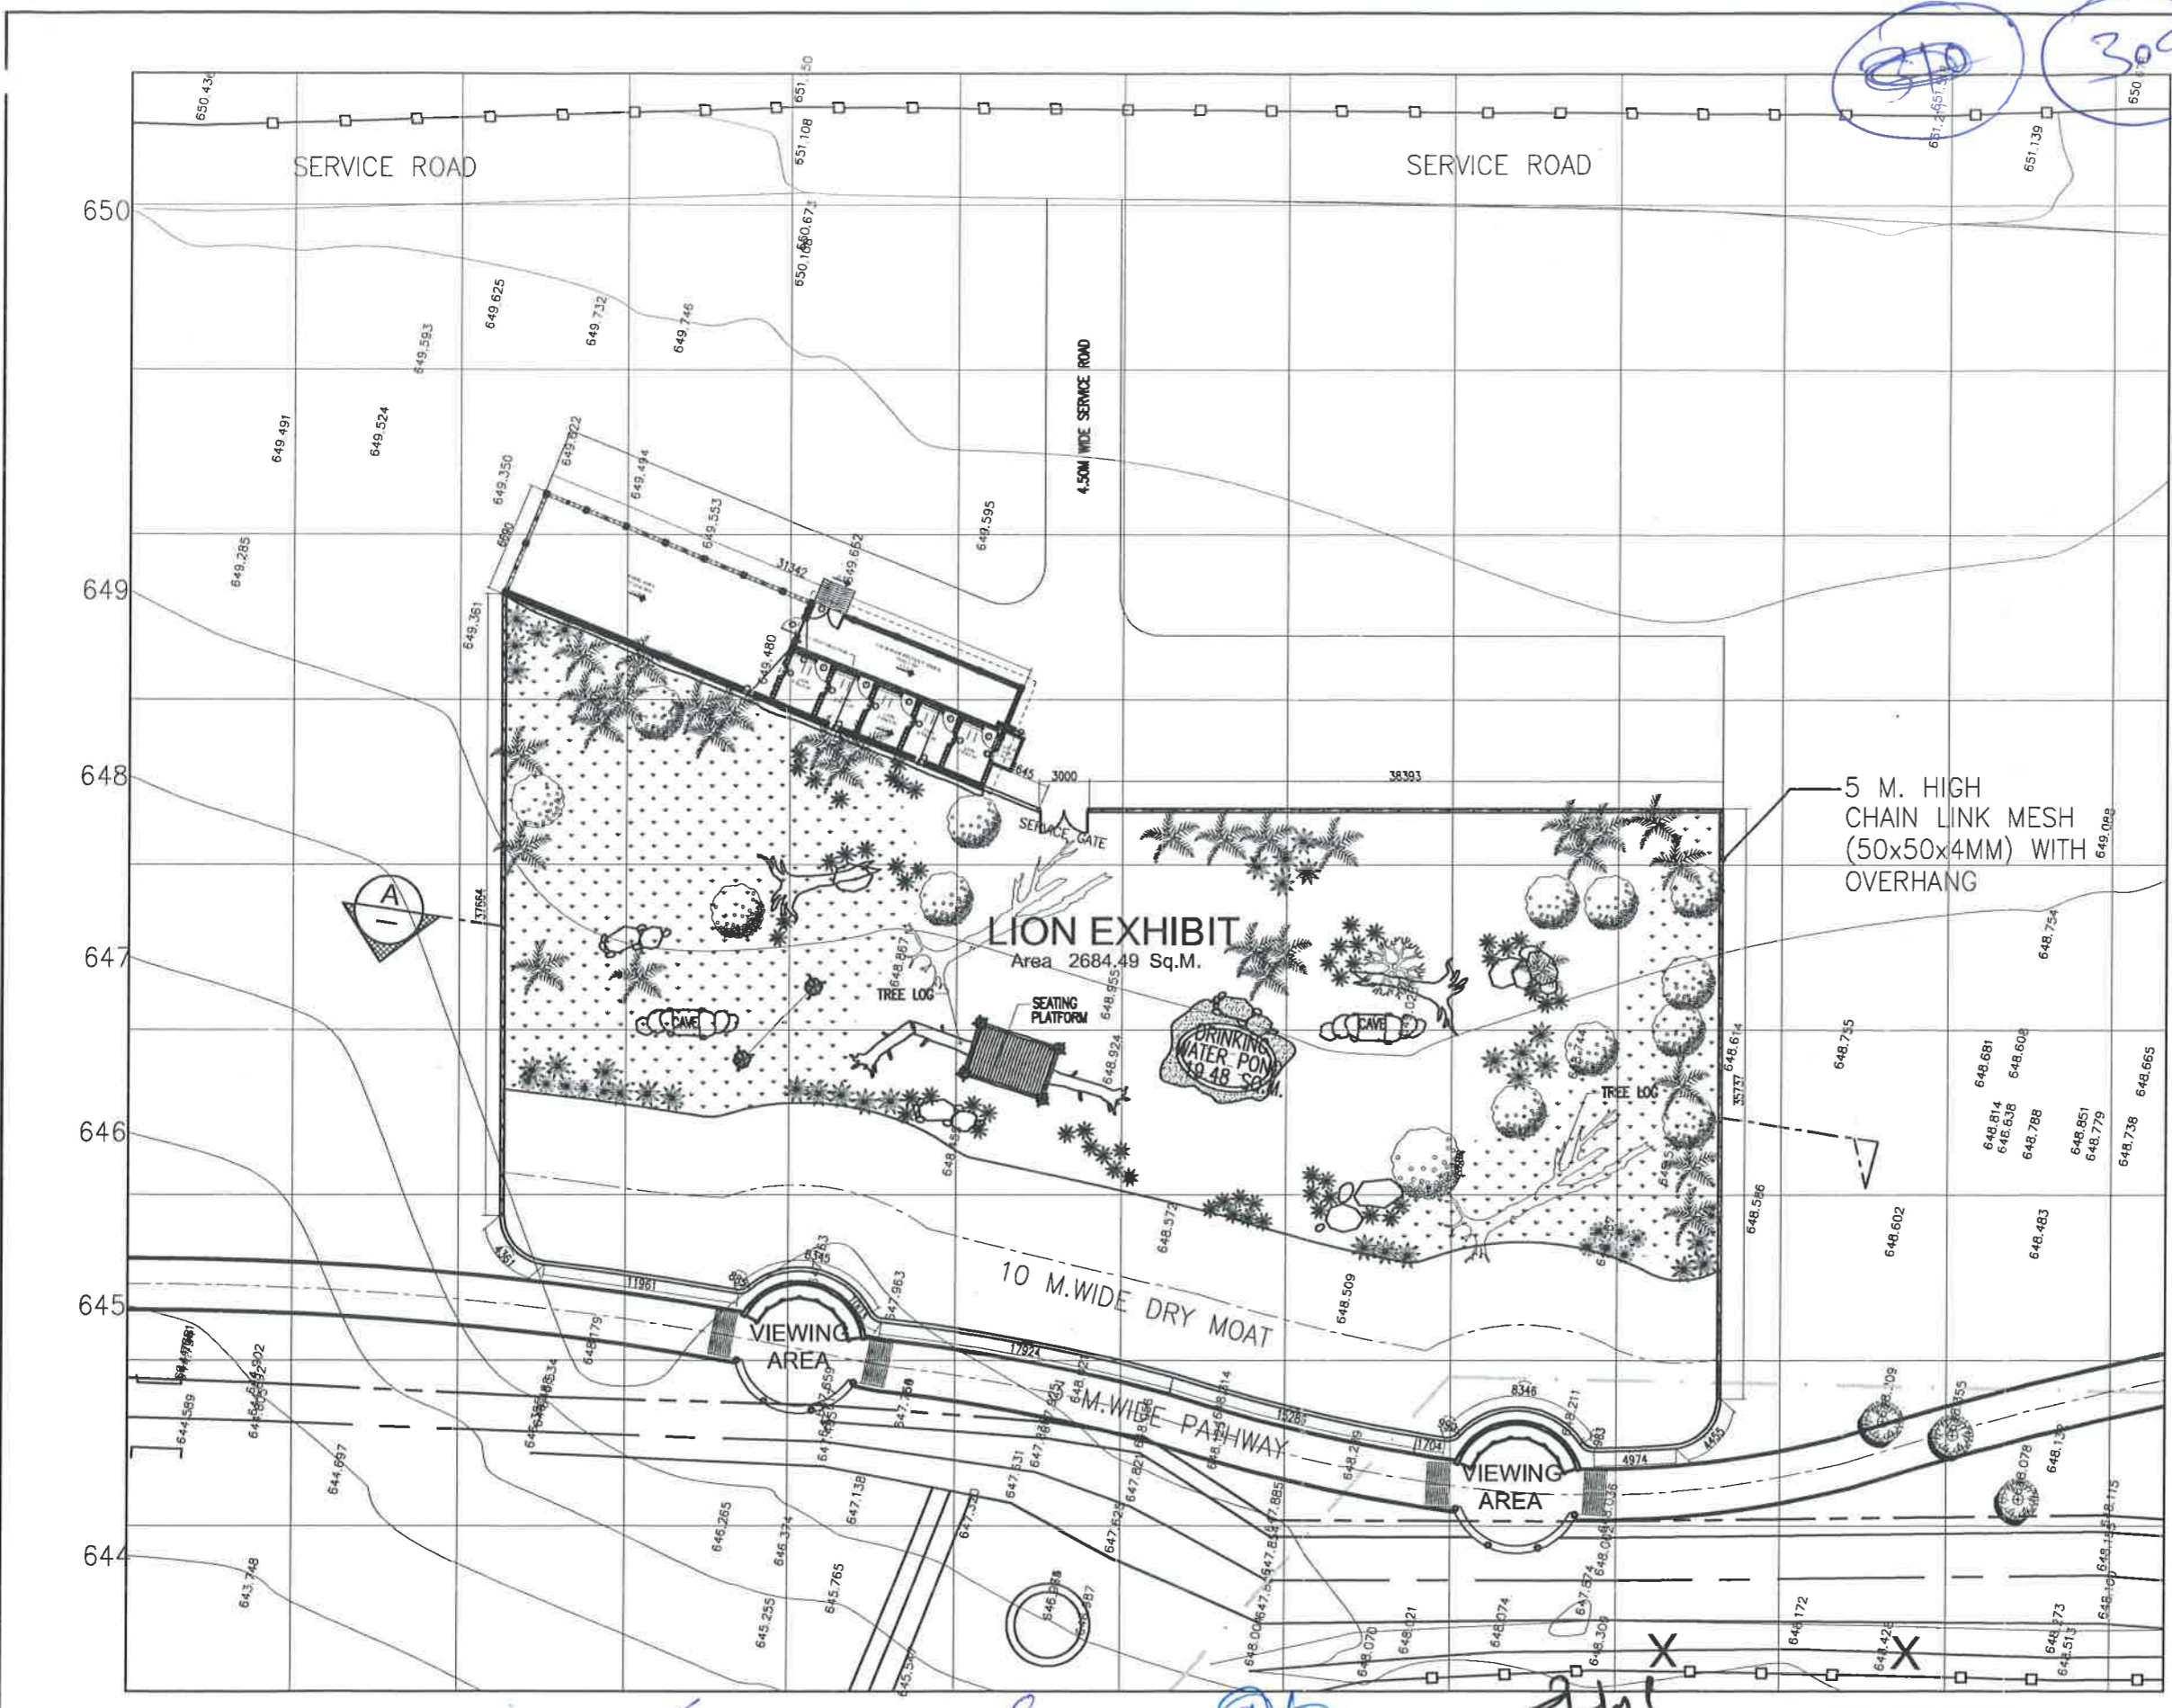

NOTES :
 This document should not be relied on or used in circumstances other than those for which it was originally prepared and for which HKS DESIGNER & CONSULTANT INTERNATIONAL COMPANY LTD. was commissioned.
 HKS DESIGNER & CONSULTANT INTERNATIONAL COMPANY LTD. accepts no responsibility for this document to any other party other than the person by whom it was commissioned. This drawing is the property of HKS and it is not allowed to reproduce its contents in any form except for the purpose for which it is intended.

AUTHORISED SIGNATORIES

DESIGN CONSULTANT :
CIVIL CONSULTANT :
STRUCTURAL CONSULTANT :
MECHANICAL CONSULTANT :
ELECTRICAL CONSULTANT :
PLUMBING CONSULTANT :
PROJECT MANAGEMENT CONSULTANT :
H.V.A.C CONSULTANT :
LIFE SUPPORT SYSTEM CONSULTANT :
OPERATIONS CONSULTANT :
SECURITY CONSULTANT :

HKS DESIGNER & CONSULTANT INTERNATIONAL COMPANY LTD.
 Site Office Telefax : +91 22 373 4007
 Web site : www.hksconsultants.com

COMMENTS

Sr.No.	COMMENT	DATE	BY

REVISIONS

Sr.No.	REVISIONS	DATE	BY

SHEET TITLE : LION EXHIBIT LAYOUT PLAN

PROJECT :
 RAJIV GANDHI ZOOLOGICAL PARK, KATRAJ.
ADDRESS :
 PUNE MUNICIPAL CORPORATION, PUNE

STAMP

DATE : 04-11-2016	SCALE = 1:400
DRAWN BY : ZOHEB	CHD BY : DR.KAZVEEN
DRAWING NO.	
HKS-PZ-LE-01	

Approved
Kazveen
 Member Secretary
 Central Zoo Authority
 Ministry of Environment & Forests
 Govt. of India, New Delhi

NOTE : GRID 10x10m

LION EXHIBIT LAYOUT PLAN
PUNE ZOO
 1:400

अभिषेक
उप अभियंता (उद्यान)
 पुणे महानगरपालिका


Duyh
कार्यकारी अभियंता (उद्यान)
 पुणे महानगरपालिका

210
 Zoo Director
 पुणे महानगरपालिका


अभिषेक
 पुणे महानगरपालिका

Maya Chhore
HKS

47-

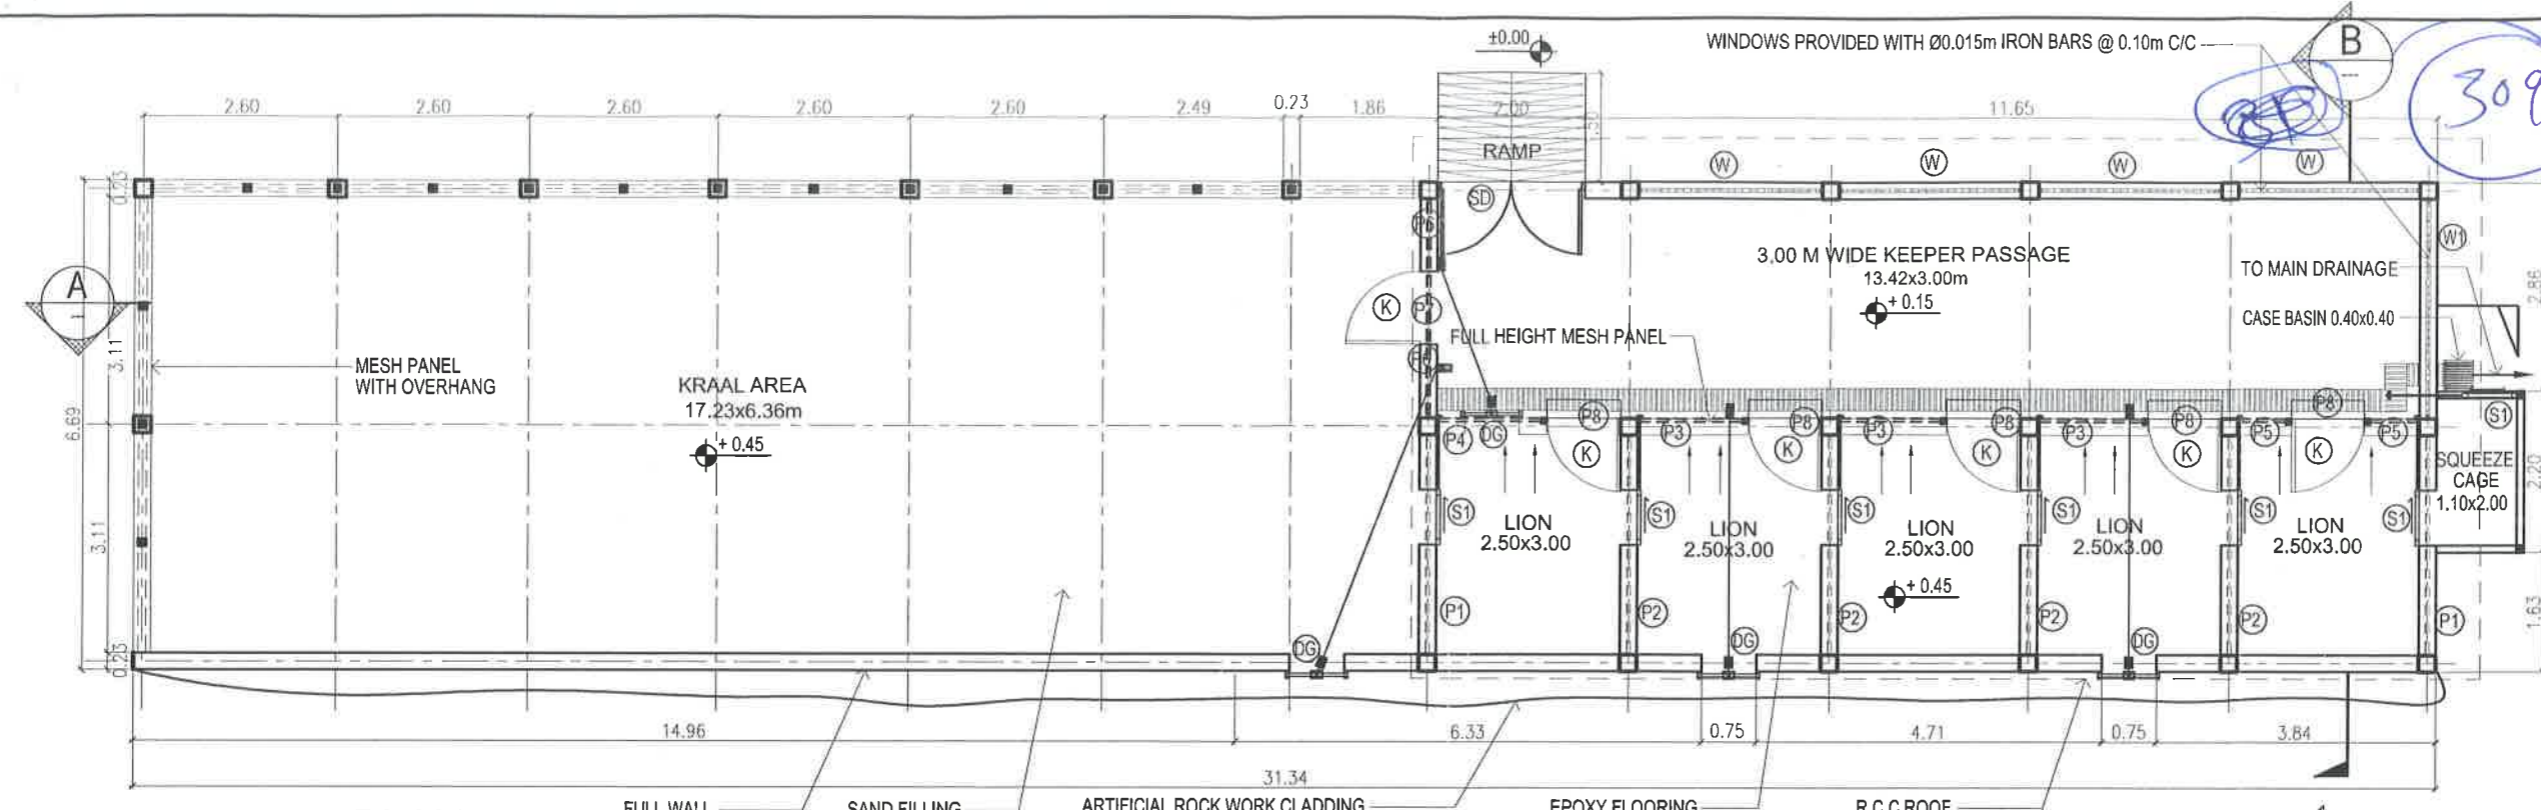

PLAN
SCALE 1:125

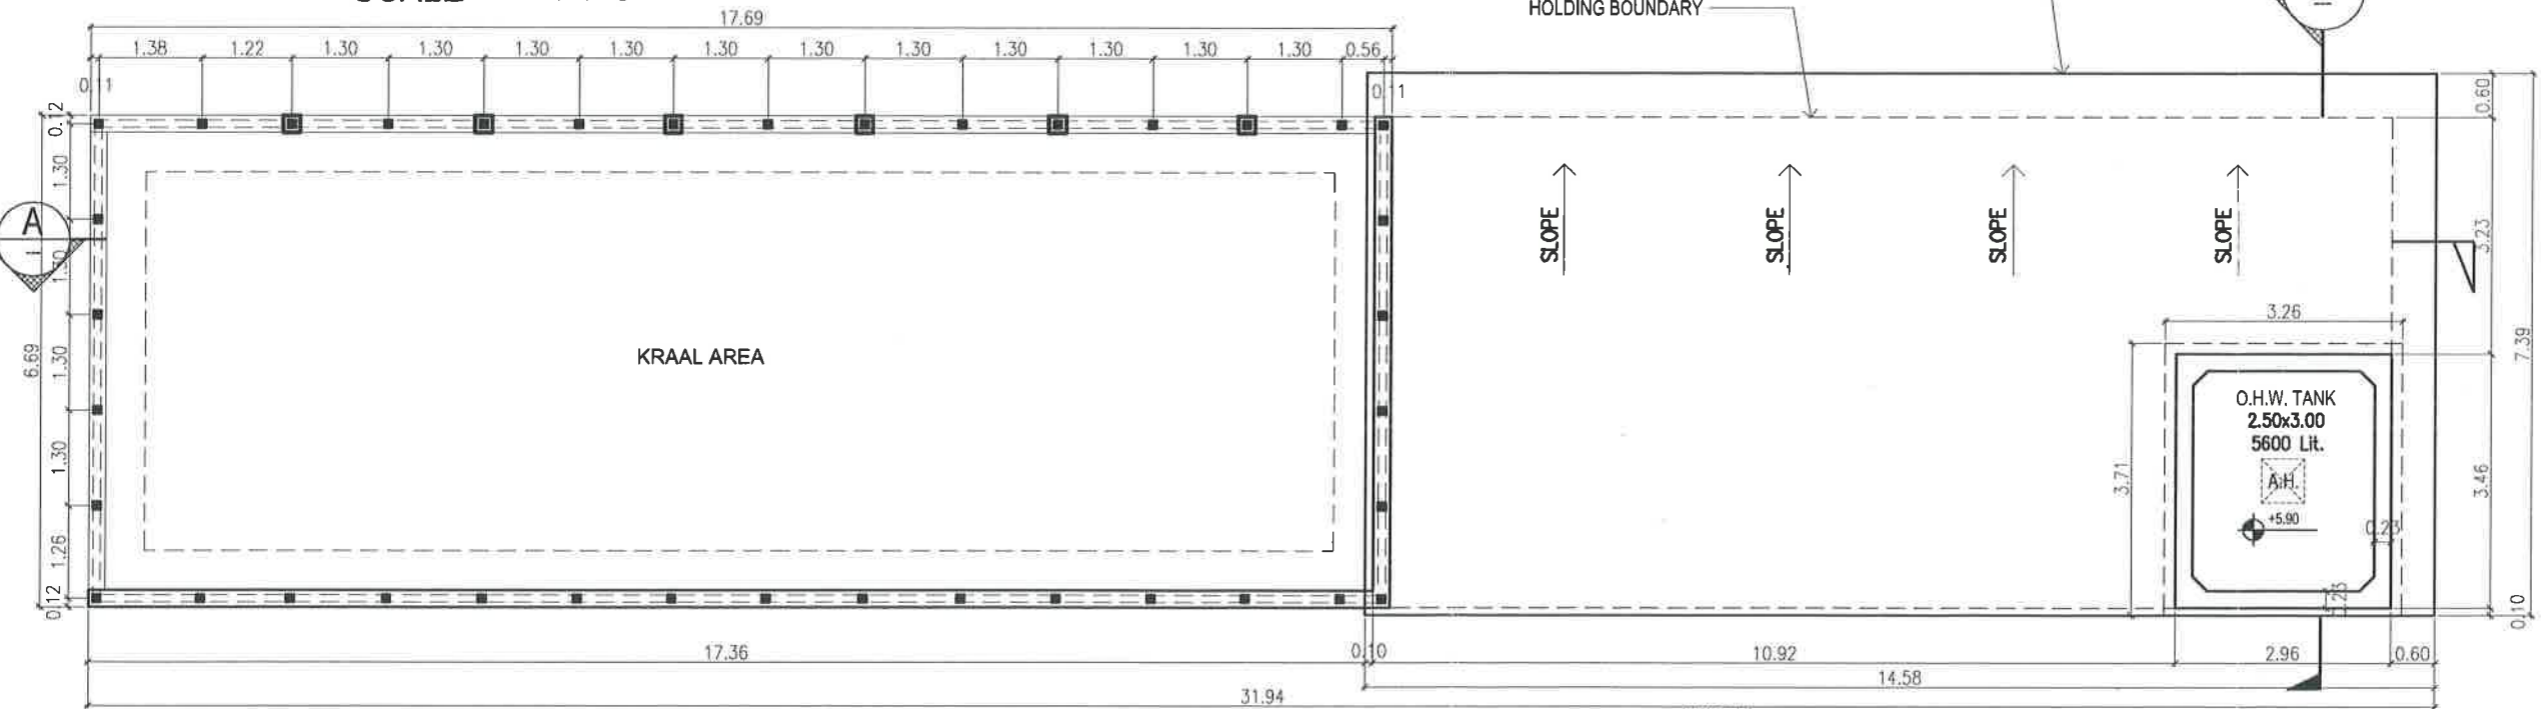


ROOF PLAN
SCALE 1:125

DOORS SCHEDULE

S.NO.	SYM.	OPENING SIZE	DESCRIPTION	QTY.
01.	K	1.00 x 2.10 m	KEEPER SWING DOOR	06
02.	S1	0.75 x 1.10 m	ANIMAL SLIDING DOOR	07
03.	SD	2.00 x 2.10 m	KEEPER SERVICE DOUBLE DOOR	01
04.	DG	0.75 x 1.00 m	DROP GATE	04
05.	W	2.50 x 1.27 m	IRON BARS WINDOW	04
06.	W1	3.00 x 1.27 m	IRON BARS WINDOW	01

MESH PANEL SCHEDULE

S.NO.	SYM.	OPENING SIZE
01.	P1	3.00 x 1.37 m
02.	P2	3.00 x 1.45 m
03.	P3	1.43 x 2.45 m
04.	P4	1.43 x 2.45 m
05.	P5	0.67 x 2.45 m
06.	P6	1.00 x 1.37 m
07.	P7	1.00 x 0.37 m
08.	P8	1.00 x 0.35 m

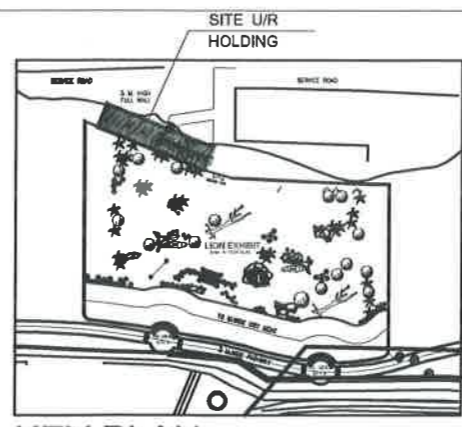

KEY PLAN
SCALE N.T.S

(Handwritten signature)
Zoo Director
Pune Municipal Corporation
HOLDING PLAN 1:100
PUNE ZOO

Notes :
 This document should not be relied on or used in any way other than those for which it was originally prepared and for which HKS DESIGNER & CONSULTANT INTERNATIONAL COMPANY LTD. was commissioned.
 HKS DESIGNER & CONSULTANT INTERNATIONAL COMPANY LTD. accepts no responsibility for this document to any other party other than the party to whom it was commissioned. This drawing is the property of — It is not allowed to reproduce its content in any form except for the purpose for which it is intended.

AUTHORISED SIGNATORIES

DESIGN CONSULTANT :
 CIVIL CONSULTANT :
 STRUCTURAL CONSULTANT :
 MECHANICAL CONSULTANT :
 ELECTRICAL CONSULTANT :
 PLUMBING CONSULTANT :
 PROJECT MANAGEMENT CONSULTANT :
 H.V.A.C CONSULTANT :
 LIFE SUPPORT SYSTEM CONSULTANT :
 OPERATIONS CONSULTANT :
 SECURITY CONSULTANT :

HKS DESIGNER & CONSULTANT INTERNATIONAL COMPANY LTD.
 Site Office Telefax : +91 22 373 4007
 Web site : www.hksconsultants.com

COMMENTS

Sr.No.	COMMENT	DATE	BY

REVISIONS

Sr.No.	REVISIONS	DATE	BY

SHEET TITLE : LION EXHIBIT HOLDING PLAN

PROJECT :
 RAJIV GANDHI ZOOLOGICAL PARK, KATRAJ.
ADDRESS :
 PUNE MUNICIPAL CORPORATION, PUNE

STAMP

DATE : 04-11-2015 SCALE : 1:100
 DRAWN BY : MANSOOR CHD BY : DR. KAZVEEN

DRAWING NO.
 HKS-PZ-LE-06

(Handwritten signatures)
निष्ठ अभियंता (उद्यान) **उप अभियंता (उद्यान)** **कार्यकारी अभियंता (उद्यान)**

